

**LAND RESERVATION FOR MAJOR ROADS:-**

S.R. NO.	CLASSIFICATION	NAME OF THE ROAD	LAND RESERVATION
1.	V-1	NATIONAL HIGHWAY N.H-2	EXISTING WIDTH WITH 60 METERS GREEN BELT ON EITHER SIDE INCLUDING 12.0 MTR. WIDE SERVICE ROAD
2.	V-2	PERIPHERAL ROAD	75 METERS ROAD WIDTH WITH 50 METERS GREEN BELT ON BOTH SIDE
3.	V-3	SECTOR DIVIDING ROAD	45 METERS WIDE ROAD.

**DRAFT DEVELOPMENT PLAN OF CONTROLLED AREAS OF HODAL-2031 AD**



SUB SECTION (1) OF SECTION -5(4) OF THE PUNJAB SCHEDULED ROADS & CONTROLLED AREAS RESTRICTION OF UN REGULATED DEVELOPMENT ACT, 1963 (PUNJAB ACT. 41 OF 1963)

**LEGEND :-**

ADDITIONAL CONTROLLED AREA BOUNDARY	
STATE BOUNDARY	
DISTRICT BOUNDARY	
MUNICIPAL BOUNDARY	
VILLAGE BOUNDARY	
NATIONAL HIGHWAY	
OTHER ROADS	
RAILWAY LINE	
KATCHA RASTA	
DRAIN	
CANAL / DISTRIBUTRY / MINOR	
EXISTING TOWN / VILLAGE ABADI	

**PROPOSALS:-**

<b>100 RESIDENTIAL</b>	
<b>200 COMMERCIAL</b>	
210 RETAIL TRADE	
220 WHOLESALE TRADE	
230 WAREHOUSING & STORAGE	
240 OFFICES AND BANKS	
250 RESTAURANT HOTELS AND TRANSIT BOARDING HOUSES DILAKSHALA, TOURIST HOUSES ETC	
260 CINEMA AND OTHER COMMERCIAL PLACES OF PUBLIC ASSEMBLY	
<b>300 INDUSTRIAL</b>	
310 SERVICES INDUSTRY	
320 LIGHT INDUSTRY	
330 EXTENSIVE INDUSTRY	
<b>400 TRANSPORT AND COMMUNICATION</b>	
420 ROADS ROAD TRANSPORT, DEPOTS AND PARKING AREAS	
450 TELEGRAPH OFFICE TELEPHONE EXCHANGE ETC	
<b>500 PUBLIC UTILITIES</b>	
510 WATER SUPPLY INSTALLATION INCLUDING TREATMENT PLANTS	
520 DRAINAGE AND SANITARY INSTALLATION INCLUDING DISPOSAL WORKS	
530 ELECTRIC POWER PLANTS, SUB-STATION ECT	
550 SOLID WASTE DISPOSAL	
<b>600 PUBLIC AND SEMI PUBLIC USES</b>	
610 GOVERNMENT ADMINISTRATIVE CENTRAL SECRETARIAT, DISTRICT OFFICES, LAW COURTS, JAILS, POLICE STATIONS, GOVERNOR AND PRESIDENTS RESIDENCE	
620 EDUCATIONAL CULTURAL AND RELIGIOUS INSTITUTIONS	
630 MEDICAL AND HEALTH INSTITUTIONS	
<b>700 OPEN SPACE</b>	
710 SPORTS ACTIVITY, STADIUM, PLAY GROUNDS	
720 PARKS	
730 OTHER RECREATIONAL USES	
740 CEMETERIES CREMATORIES ECT	
750 FUEL FILLING STATIONS AND BUS QUEUES SHELTERS	
<b>800 AGRICULTURAL ZONE</b>	
<b>900 SPECIAL ZONE.</b>	
Godawan / Warehouse for agriculture products.	
SECTOR NO.	
SECTOR DENSITY	
LOCATION CODE	

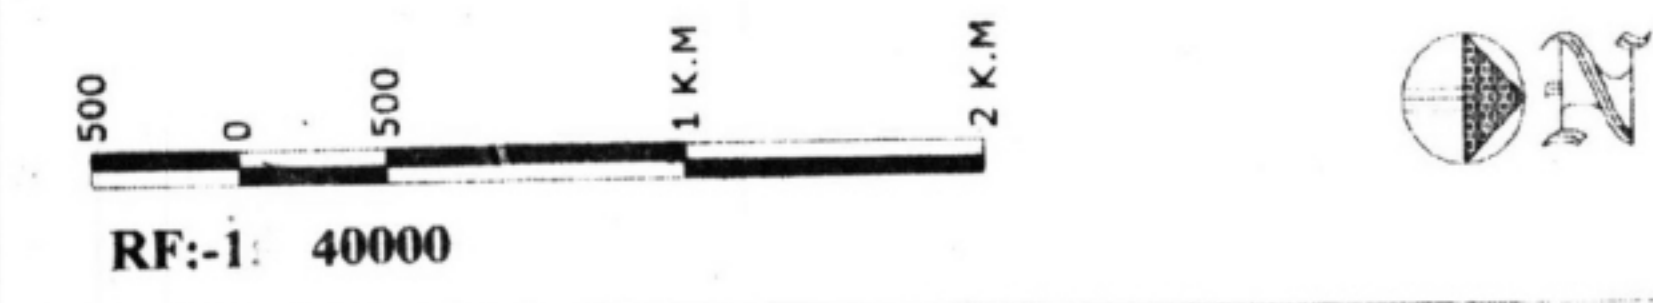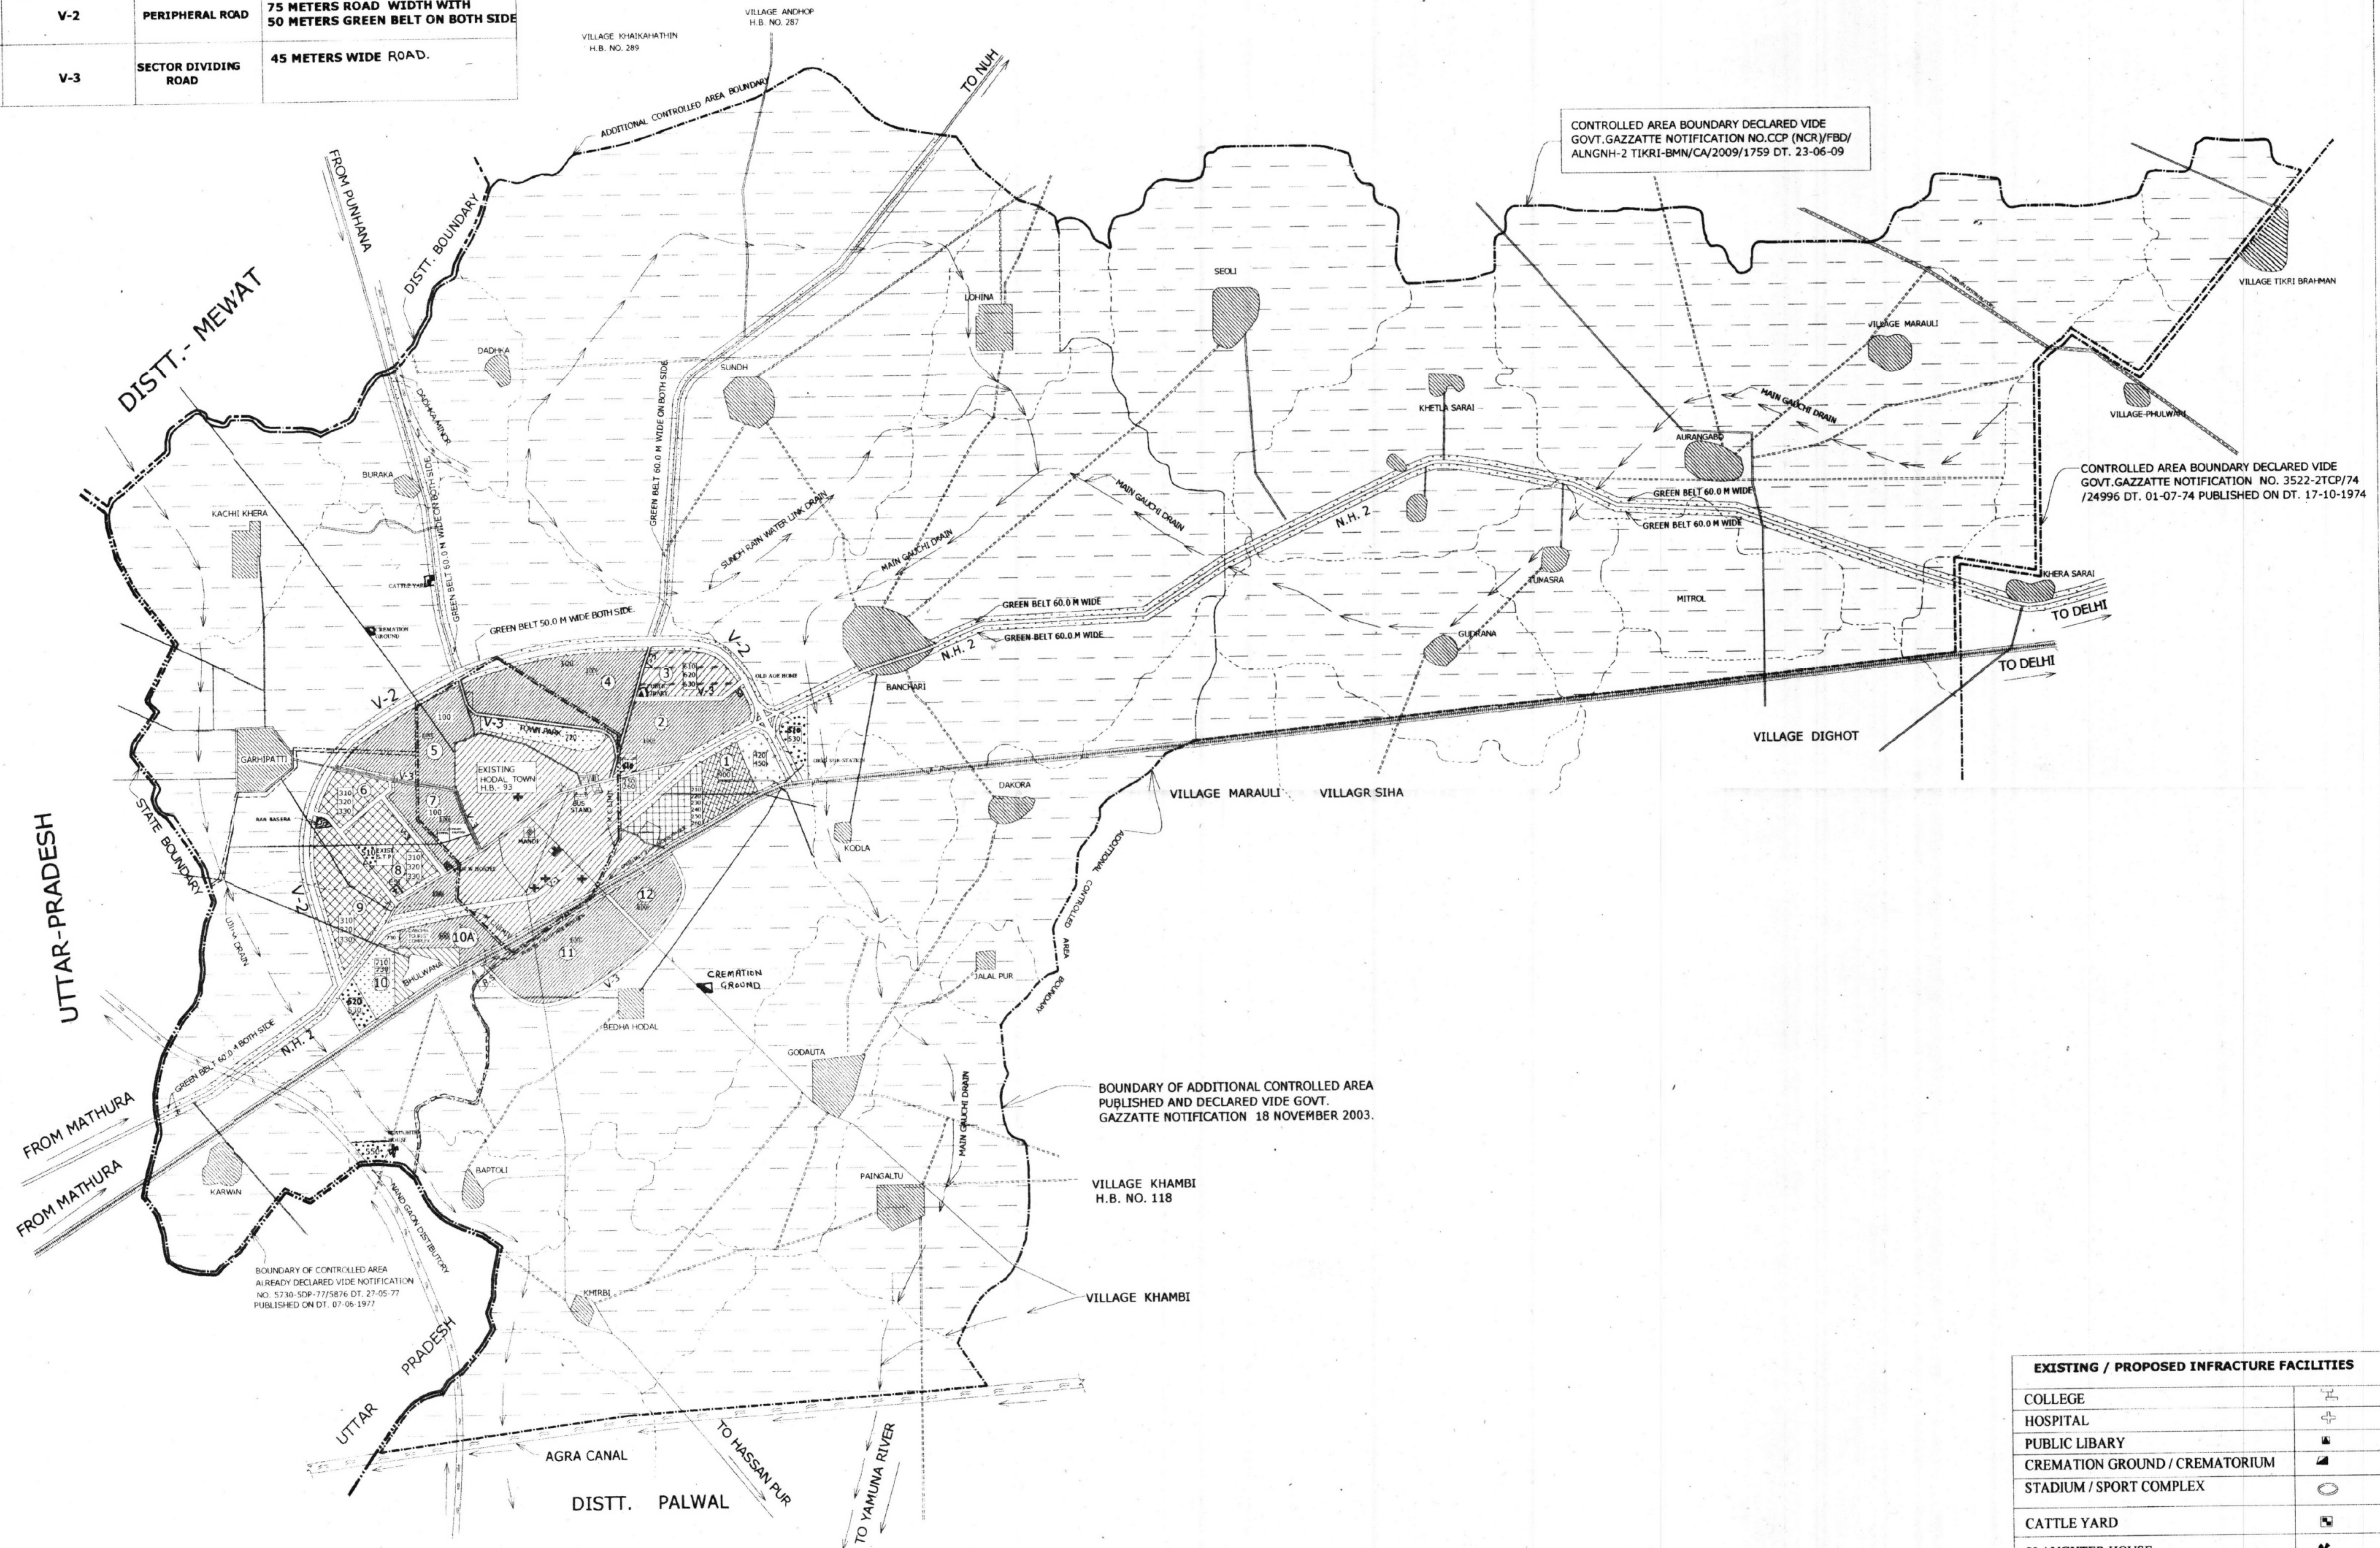

DRG. NO. D.T.P. (PAL) 09/10 DATED 4-5-2010/29-6-11

JUNIOR DRAFT MAN *[Signature]*  
DISTT. TOWN PLANNER *[Signature]*

SENIOR TOWN PLANNER FARIDABAD *[Signature]*  
CHIEF CO-ORDINATOR PLANNER, NCR. HARYANA, PANCHKULA *[Signature]*  
DIRECTOR TOWN AND COUNTRY PLANNING HARYANA, CHANDIGARH *[Signature]*

DEPTT. OF T&C. PLG. HARYANA

EXISTING / PROPOSED INFRASTRUCTURE FACILITIES	
COLLEGE	
HOSPITAL	
PUBLIC LIBRARY	
CREMATION GROUND / CREMATORIUM	
STADIUM / SPORT COMPLEX	
CATTLE YARD	
SLAUGHTER HOUSE	
WORKING WOMEN HOSTEL	
OLD AGE HOME	
GRID SUB-STATION	
FIRE STATION	
MINI SECRETARIAT COMPLEX.	
BUS STAND	
RAN BASERA	
E.S.I DESPENSARY	